


V-5000
 SERVICE: LIQUID BLOWCASE
 OD: 12" OD
 LENGTH: 1'-0 7/8" OAL
 MATERIAL: SA-414G

E-101/E-102/E-103
 JATCO BTEX ELIMINATOR SYSTEM
 SHELL AND TUBE GLYCOL CONDENSER


P&ID BILL OF MATERIAL		
QTY	TAG	DESCRIPTION
1	ABV-1100	3-WAY ACTUATED BALL VALVE
1	ABV-1200	2", 3-WAY ACTUATED BALL VALVE
1	BA-001	2" BALL VALVE STAINLESS FULL-PORT
1	BB-001	1/4" BLOCK & BLEED
5	CV-001	1" CHECK VALVE STAINLESS
2	CV-002	1/2" CHECK VALVE STAINLESS
1	CV-004	1" CHECK VALVE
1	FA-1101	FLAME ARRESTOR 2" 70602/D-C4R OP20
1	ME-1100	MIST EXTRACTOR
1	LG-1000	LEVEL GAUGE COCKS
1	LS-1000	INVALCO SWITCH JM5001x
1	LSH-1000	JATCO HIGH LEVEL CONTROL W/INVALCO SWITCH INV49
1	PI-1100	GAUGE 0-15 OZ.
1	PSV-1000	1" 100 PSI PRV
1	PSV-1100	2" 12 OZ PRV
1	PSV-1101	150 PSI PRV
1	PY-1000	1/4", 3-WAY PILOT VALVE
1	PY-1001	HUMPHREY F3002
1	PY-1002	LOW PRESSURE 1/4", 3-WAY PILOT VALVE
1	PY-1101	3-WAY PILOT VALVE HQ3
1	PY-1103	K-DYNE R-11 RESET CCO1
1	SP-1100	JATCO STEAM SEPARATOR

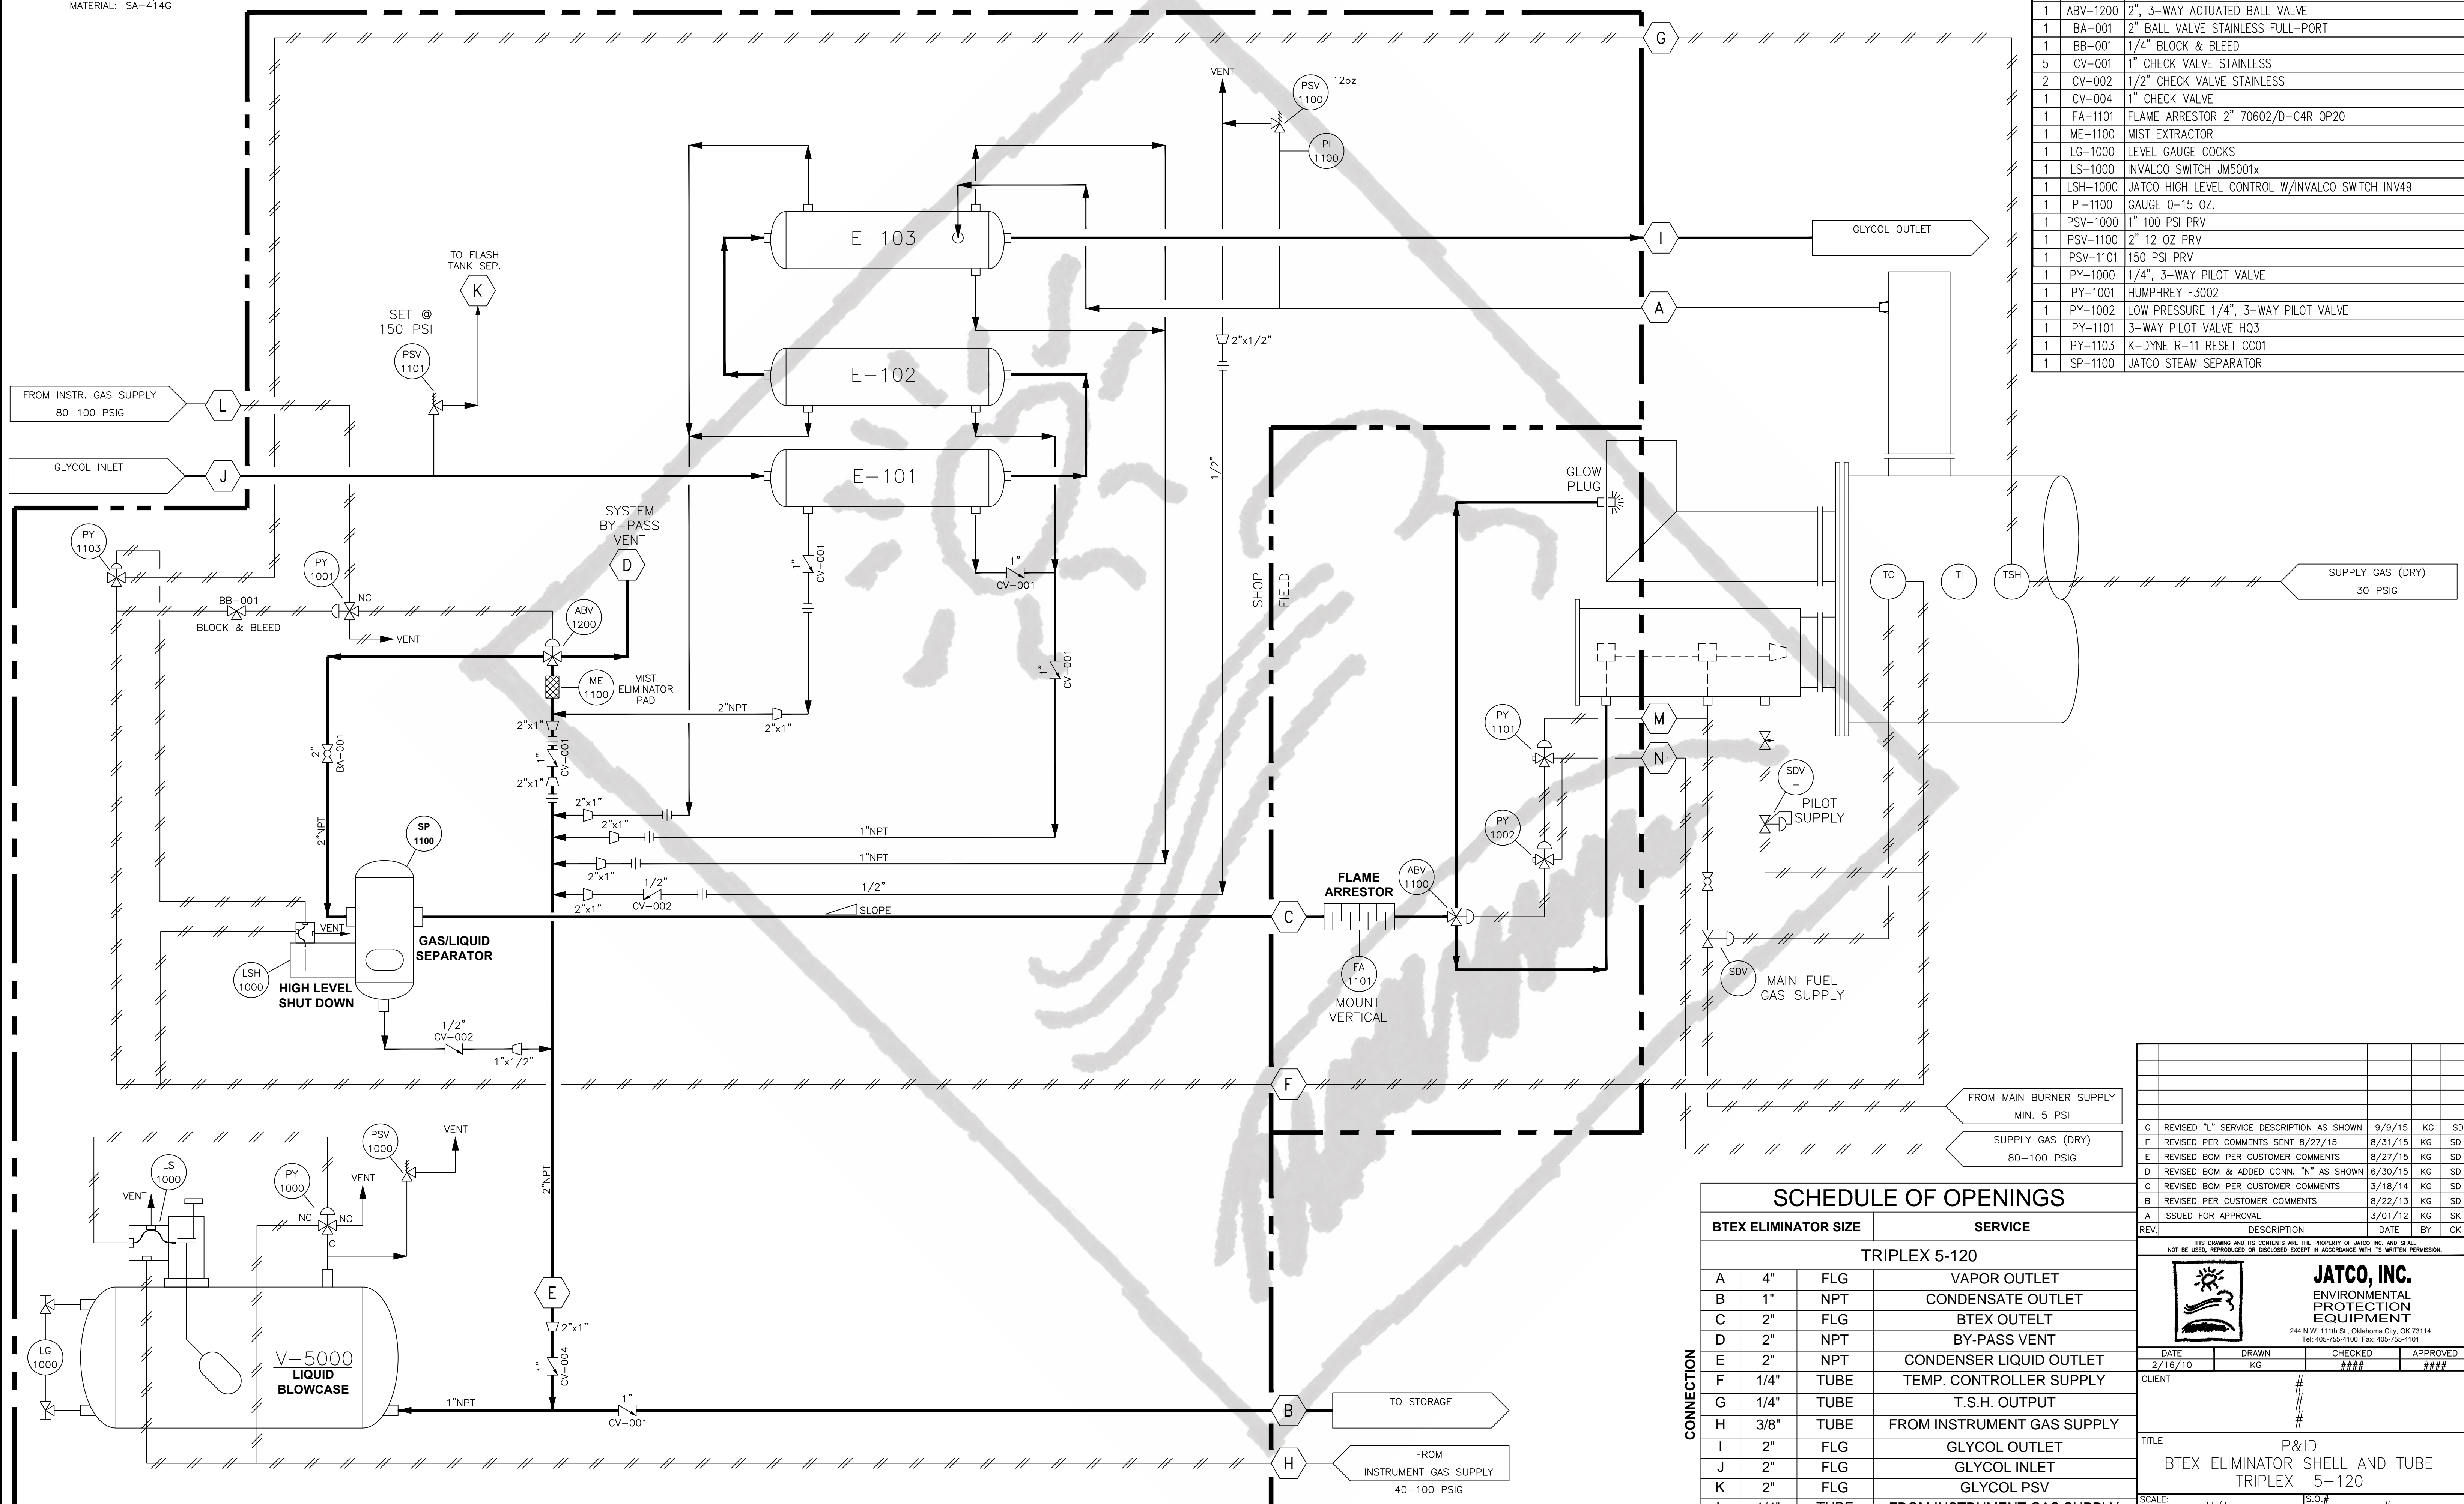

REV	DESCRIPTION	DATE	BY	CHK
G	REVISED "L" SERVICE DESCRIPTION AS SHOWN	9/9/15	KG	SD
F	REVISED PER COMMENTS SENT 8/27/15	8/31/15	KG	SD
E	REVISED BOM PER CUSTOMER COMMENTS	8/27/15	KG	SD
D	REVISED BOM & ADDED CONN. "N" AS SHOWN	6/30/15	KG	SD
C	REVISED BOM PER CUSTOMER COMMENTS	3/18/14	KG	SD
B	REVISED PER CUSTOMER COMMENTS	8/22/13	KG	SD
A	ISSUED FOR APPROVAL	3/01/12	KG	SK

BTEX ELIMINATOR SIZE		SERVICE	
TRIPLEX 5-120			
A	4"	FLG	VAPOR OUTLET
B	1"	NPT	CONDENSATE OUTLET
C	2"	FLG	BTEX OUTLET
D	2"	NPT	BY-PASS VENT
E	2"	NPT	CONDENSER LIQUID OUTLET
F	1/4"	TUBE	TEMP. CONTROLLER SUPPLY
G	1/4"	TUBE	T.S.H. OUTPUT
H	3/8"	TUBE	FROM INSTRUMENT GAS SUPPLY
I	2"	FLG	GLYCOL OUTLET
J	2"	FLG	GLYCOL INLET
K	2"	FLG	GLYCOL PSV
L	1/4"	TUBE	FROM INSTRUMENT GAS SUPPLY
M	1/4"	TUBE	FROM MAIN BURNER FG SUPPLY
N	1/4"	TUBE	FROM INSTRUMENT GAS SUPPLY

THIS DRAWING AND ITS CONTENTS ARE THE PROPERTY OF JATCO INC. AND SHALL NOT BE USED, REPRODUCED OR DISCLOSED EXCEPT IN ACCORDANCE WITH ITS WRITTEN PERMISSION.

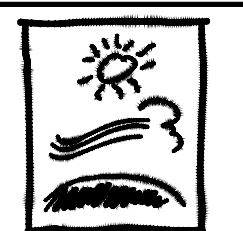

JATCO, INC.
 ENVIRONMENTAL PROTECTION EQUIPMENT
 244 N.W. 111th St., Oklahoma City, OK 73114
 Tel: 405-755-4100 Fax: 405-755-4101

DATE	DRAWN	CHECKED	APPROVED
2/16/10	KG	###	###

CLIENT: #

TITLE: P&ID BTEX ELIMINATOR SHELL AND TUBE TRIPLEX 5-120

SCALE: N/A S.O.# #

DRAWING NUMBER	SHEETS	REV
10022	SHT# 1 OF 1	G